

Notes:

1. Provide fire and smoke alarm as required.
2. Churches with fixed seating are except from the requirement for a fire sprinkler system. Do not provide a fire sprinkler system.
3. The Occupancy Class for the building is A-3.
4. The building Construction Type is 2-B

Occupancy Load Calculations:
Pew seating is based on 18" per Occupant.
Min. Space between pews is 36" (See plans)

1ST floor Sanctuary fixed pews 261



Building Area Calculations:

1st Floor area used	7,297 sq. ft.
Un-finished space	909
Covered Entry - Portico	828
Total 1st Floor area	9,034 sq. ft.
2nd Floor Dressing Room	385
Un-Finished Balcony	3,357
Total Building Area	12,776 sq. ft.

Minimum Plumbing Fixture Calculation:


Total Occupant Load: 240			
Women: 120			
Men: 120			
Fixture:	Code:	Required:	Provided:
Men's Toilets/Urinals:	1/150	1	6
Women's Toilets:	1/75	2	6
Lav's Men's:	1/200	1	6
Lav's Women's:	1/200	1	6
Drinking Fountain:	1/1,000	1	1 High Low (HK)
Service Sink	1	1	2

BAPTISTRY TO BE :
RAINSVILLE CHURCH PEW CO. ATLANTA
MODEL RC-90 W/ WINDOW.
OR APPROVED EQUAL.
COLOR AS PER OWNER
W/ HEATER

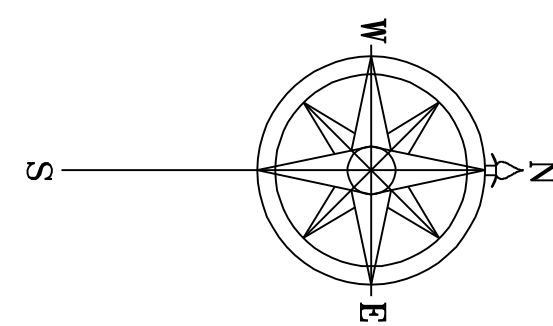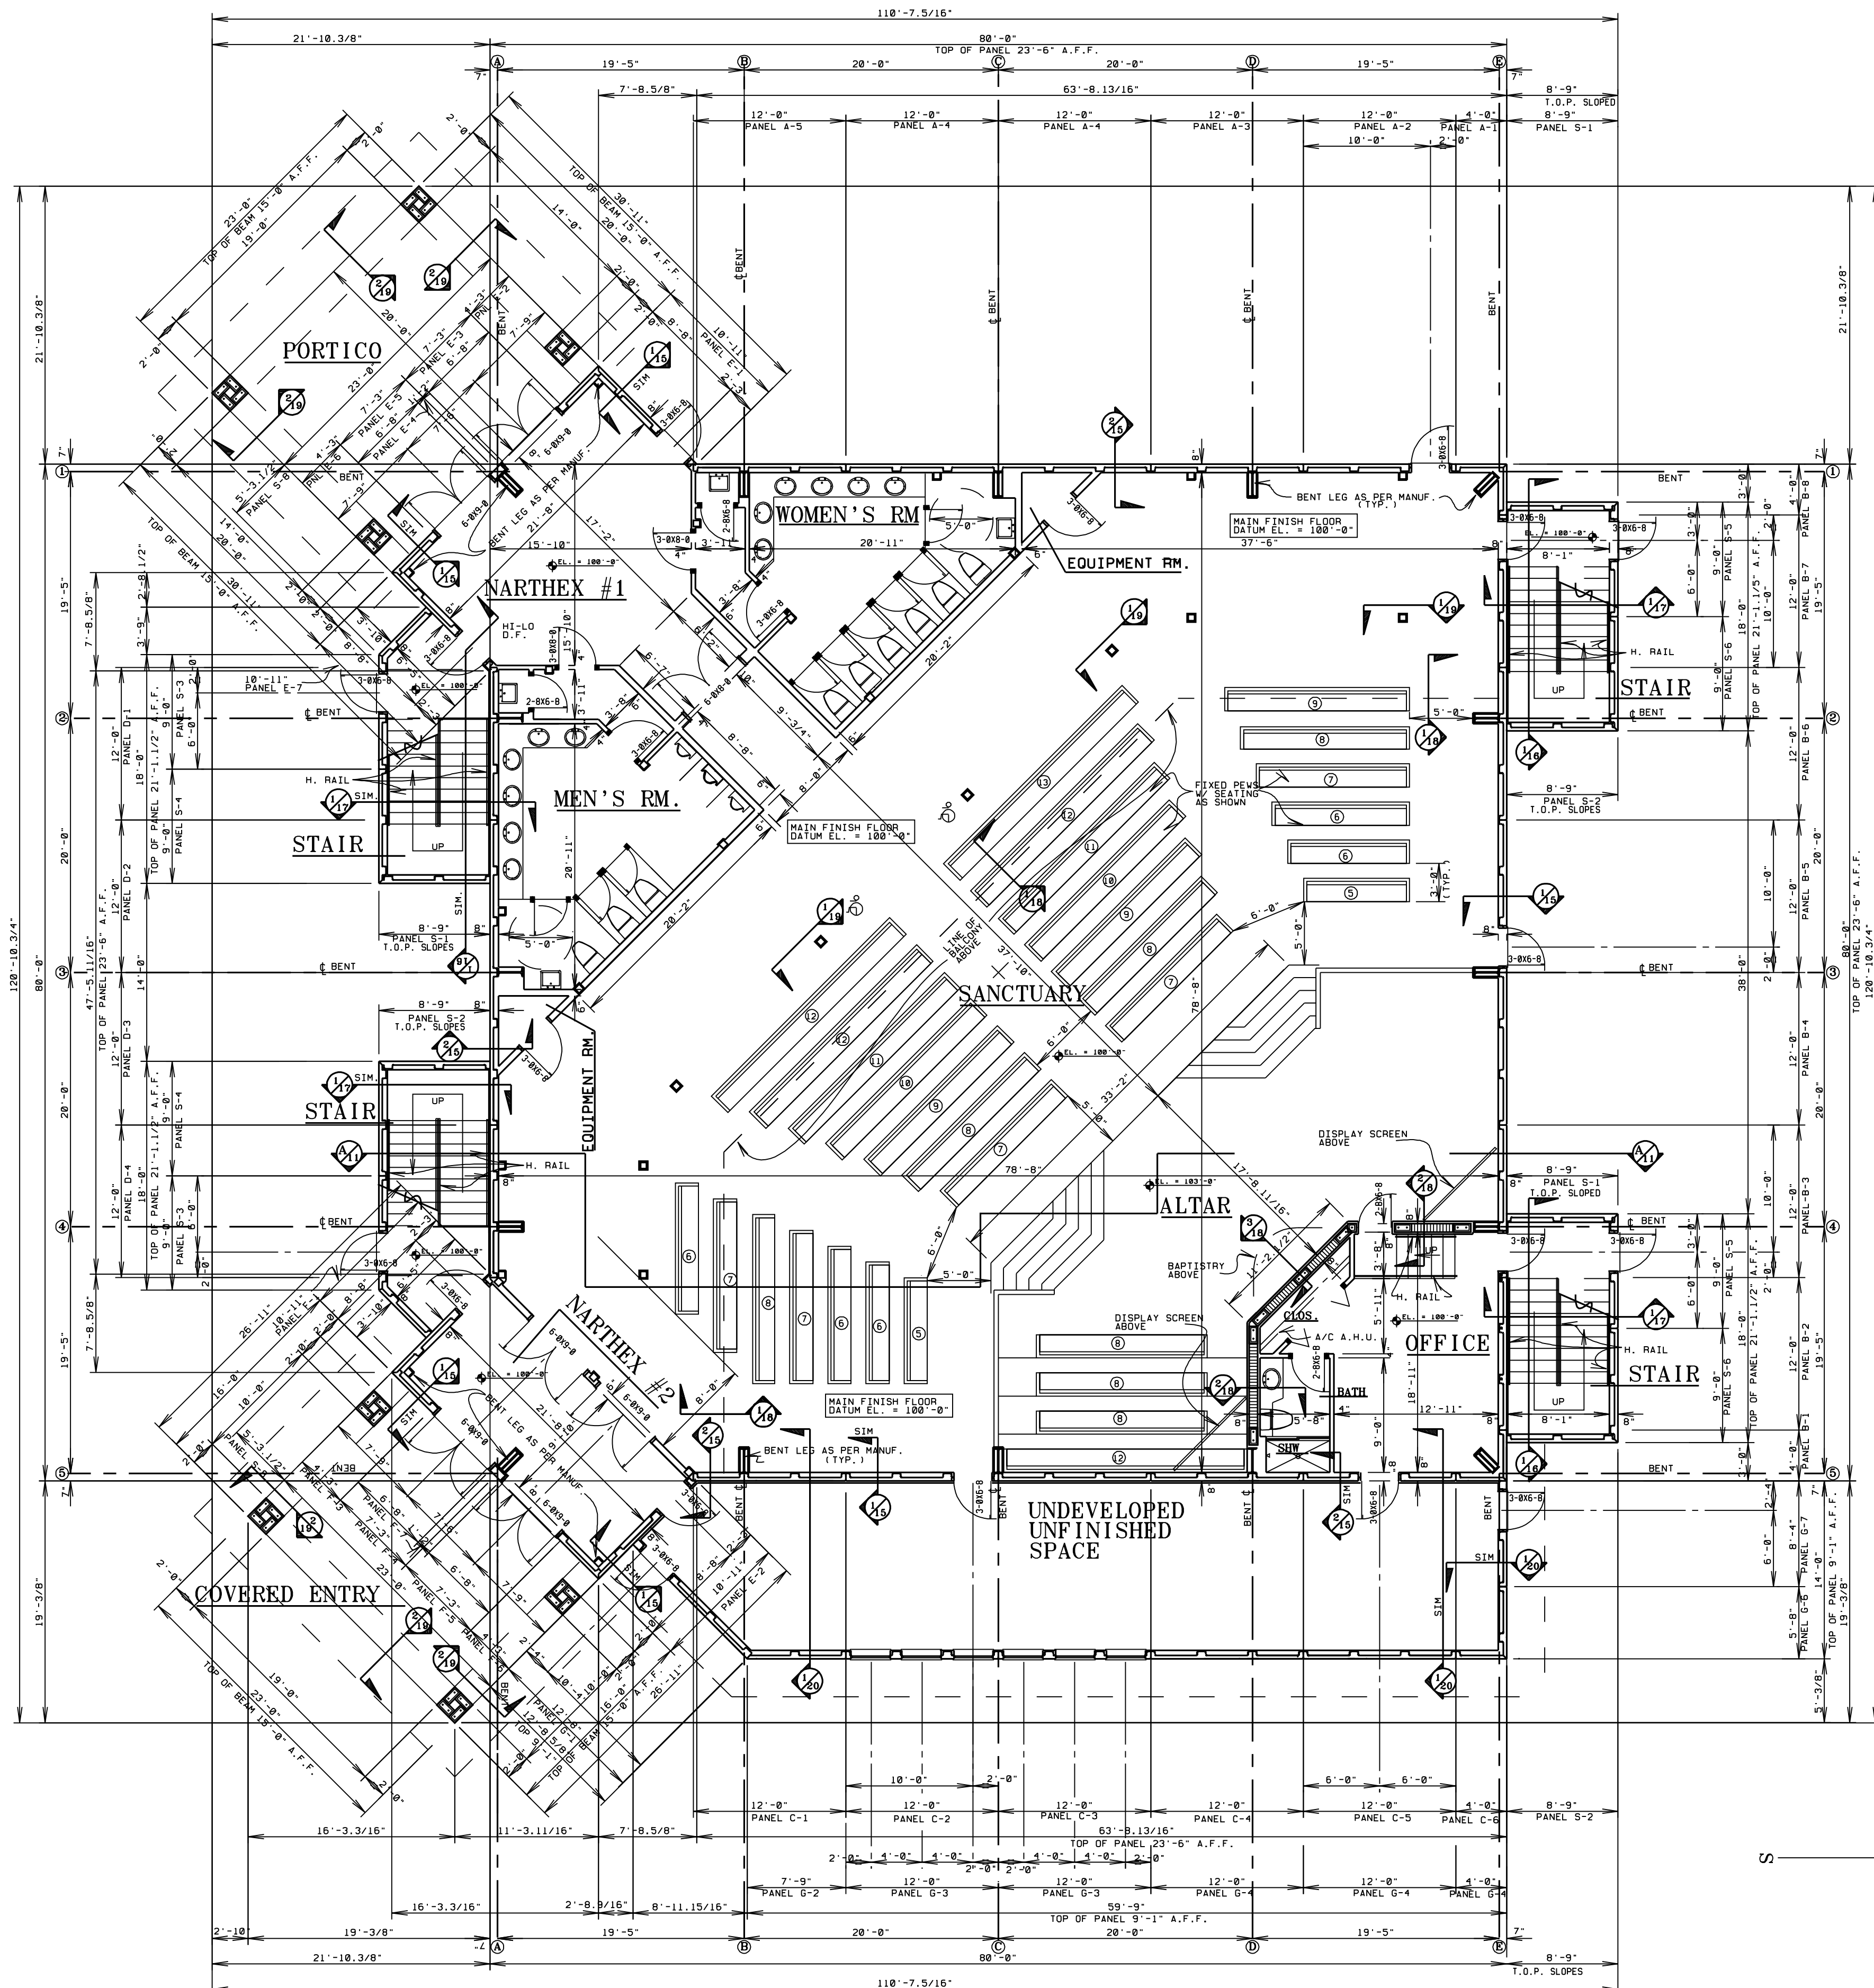

1st FL. FLOOR PLAN

- SCALE: 1/8" = 1'-0" -
ALL GLASS TO BE TINTED

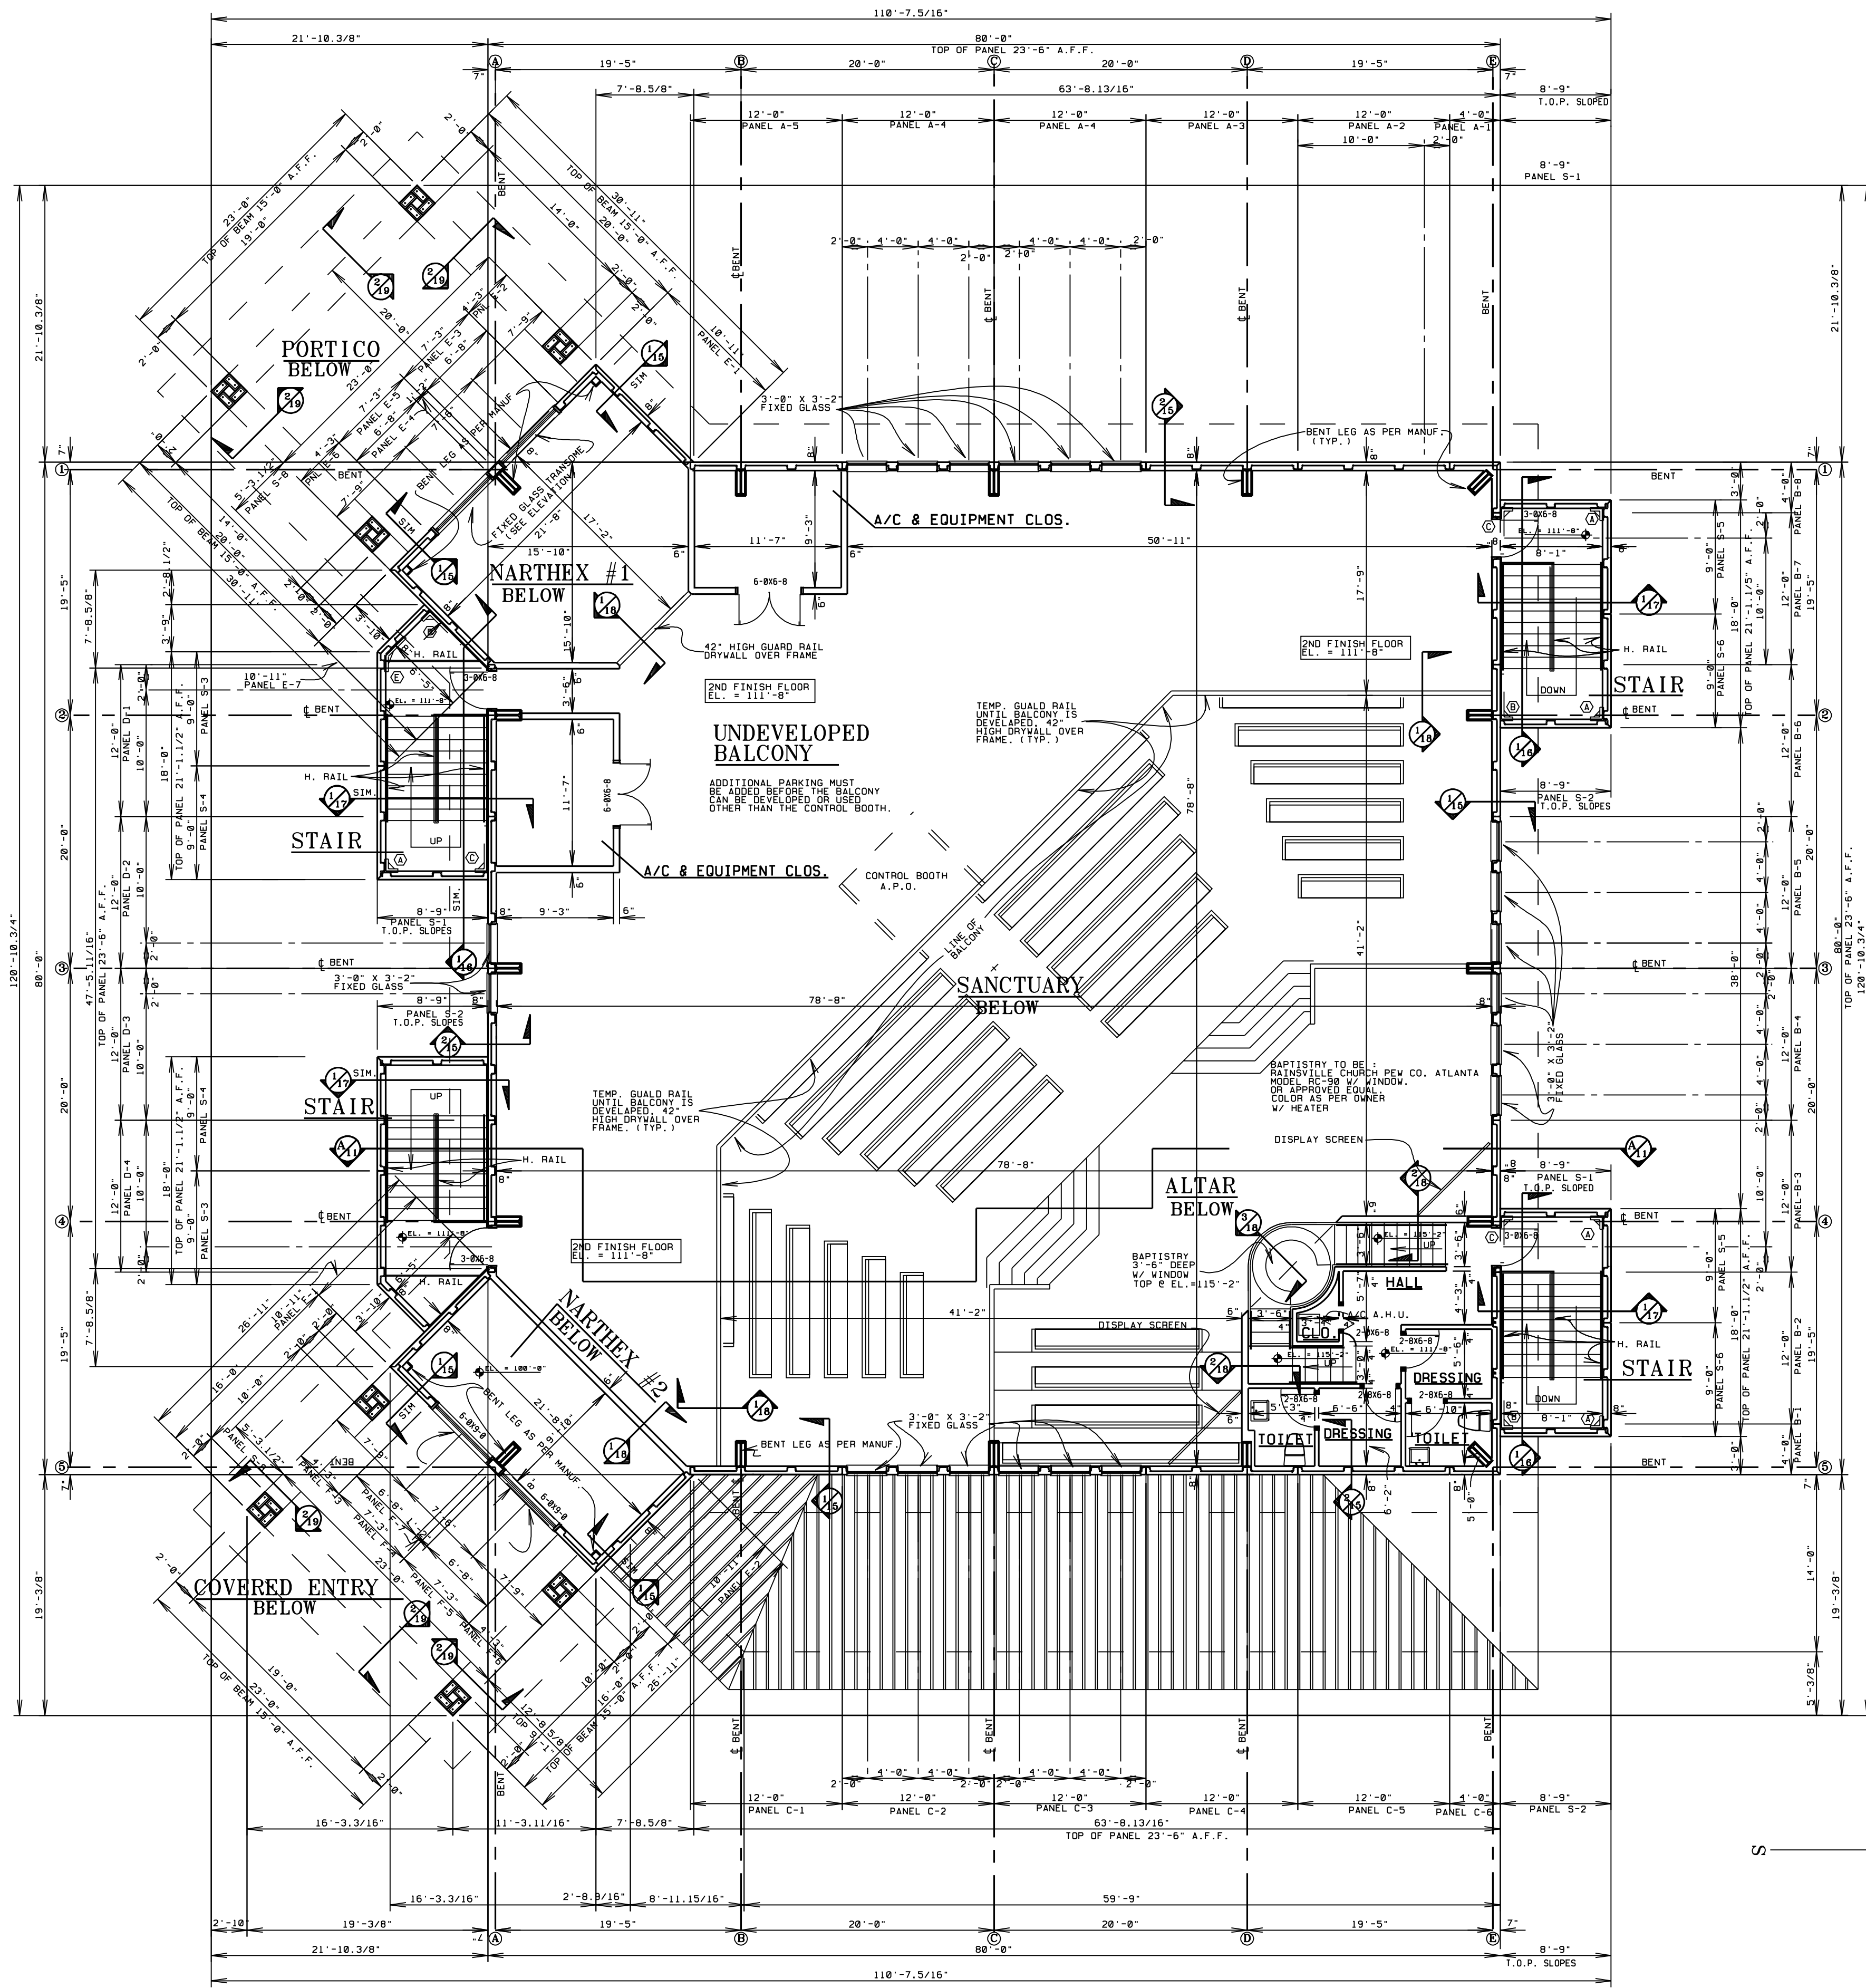

Notes:

1. Provide fire and smoke alarm as required.
2. Churches with fixed seating are except from the requirement for a fire sprinkler system. Do not provide a fire sprinkler system.
3. The Occupancy Class for the building is A-3.
4. The building Construction Type is 2-B

Occupancy Load Calculations:
 Pew seating is based on 18" per Occupant.
 Min. Space between pews is 36" (See plans)

1ST floor Sanctuary fixed pews 261

Building Area Calculations:

1st Floor area used	7,297 sq. ft.
Un-finished space	909
Covered Entry - Portico	828
Total 1st Floor area	9,034 sq. ft.
2nd Floor Dressing Room	385
Un-Finished Balcony	3,357
Total Building Area	12,776 sq. ft.

Minimum Plumbing Fixture Calculation:

Total Occupant Load: 240			
Women: 120			
Men: 120			
Fixture:	Code:	Required:	Provided:
Men's Toilets/Urinals:	1/150	1	6
Women's Toilets:	1/75	2	6
Lav's Men's:	1/200	1	6
Lav's Women's:	1/200	1	1
Drinking Fountain:	1/1,000	1	2 High Low (HK)
Service Sink	1	1	

BAPTISTRY TO BE :
 RAINVILLE CHURCH PEW CO. ATLANTA
 MODEL RC-90 W/ WINDOW.
 OR APPROVED EQUAL.
 COLOR AS PER OWNER
 W/ HEATER

2nd FL. FLOOR PLAN

- SCALE: 1/8" = 1'-0" -

ALL GLASS TO BE TINTED


L. BRUCE KILBY, INC. 2006


PROJECT: 05082	REVISID:
DATE: 09/06	
DRAWN BY: LRB	

A NEW SANCTUARY FOR:

FLORIDA

L. BRUCE KILBY, DESIGNS

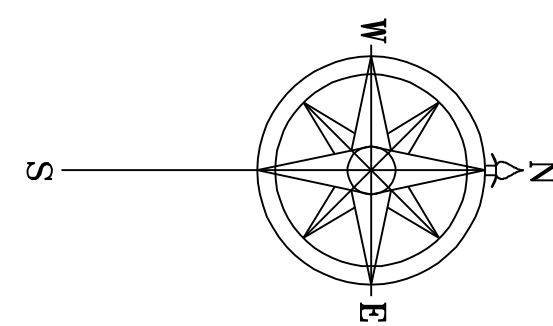

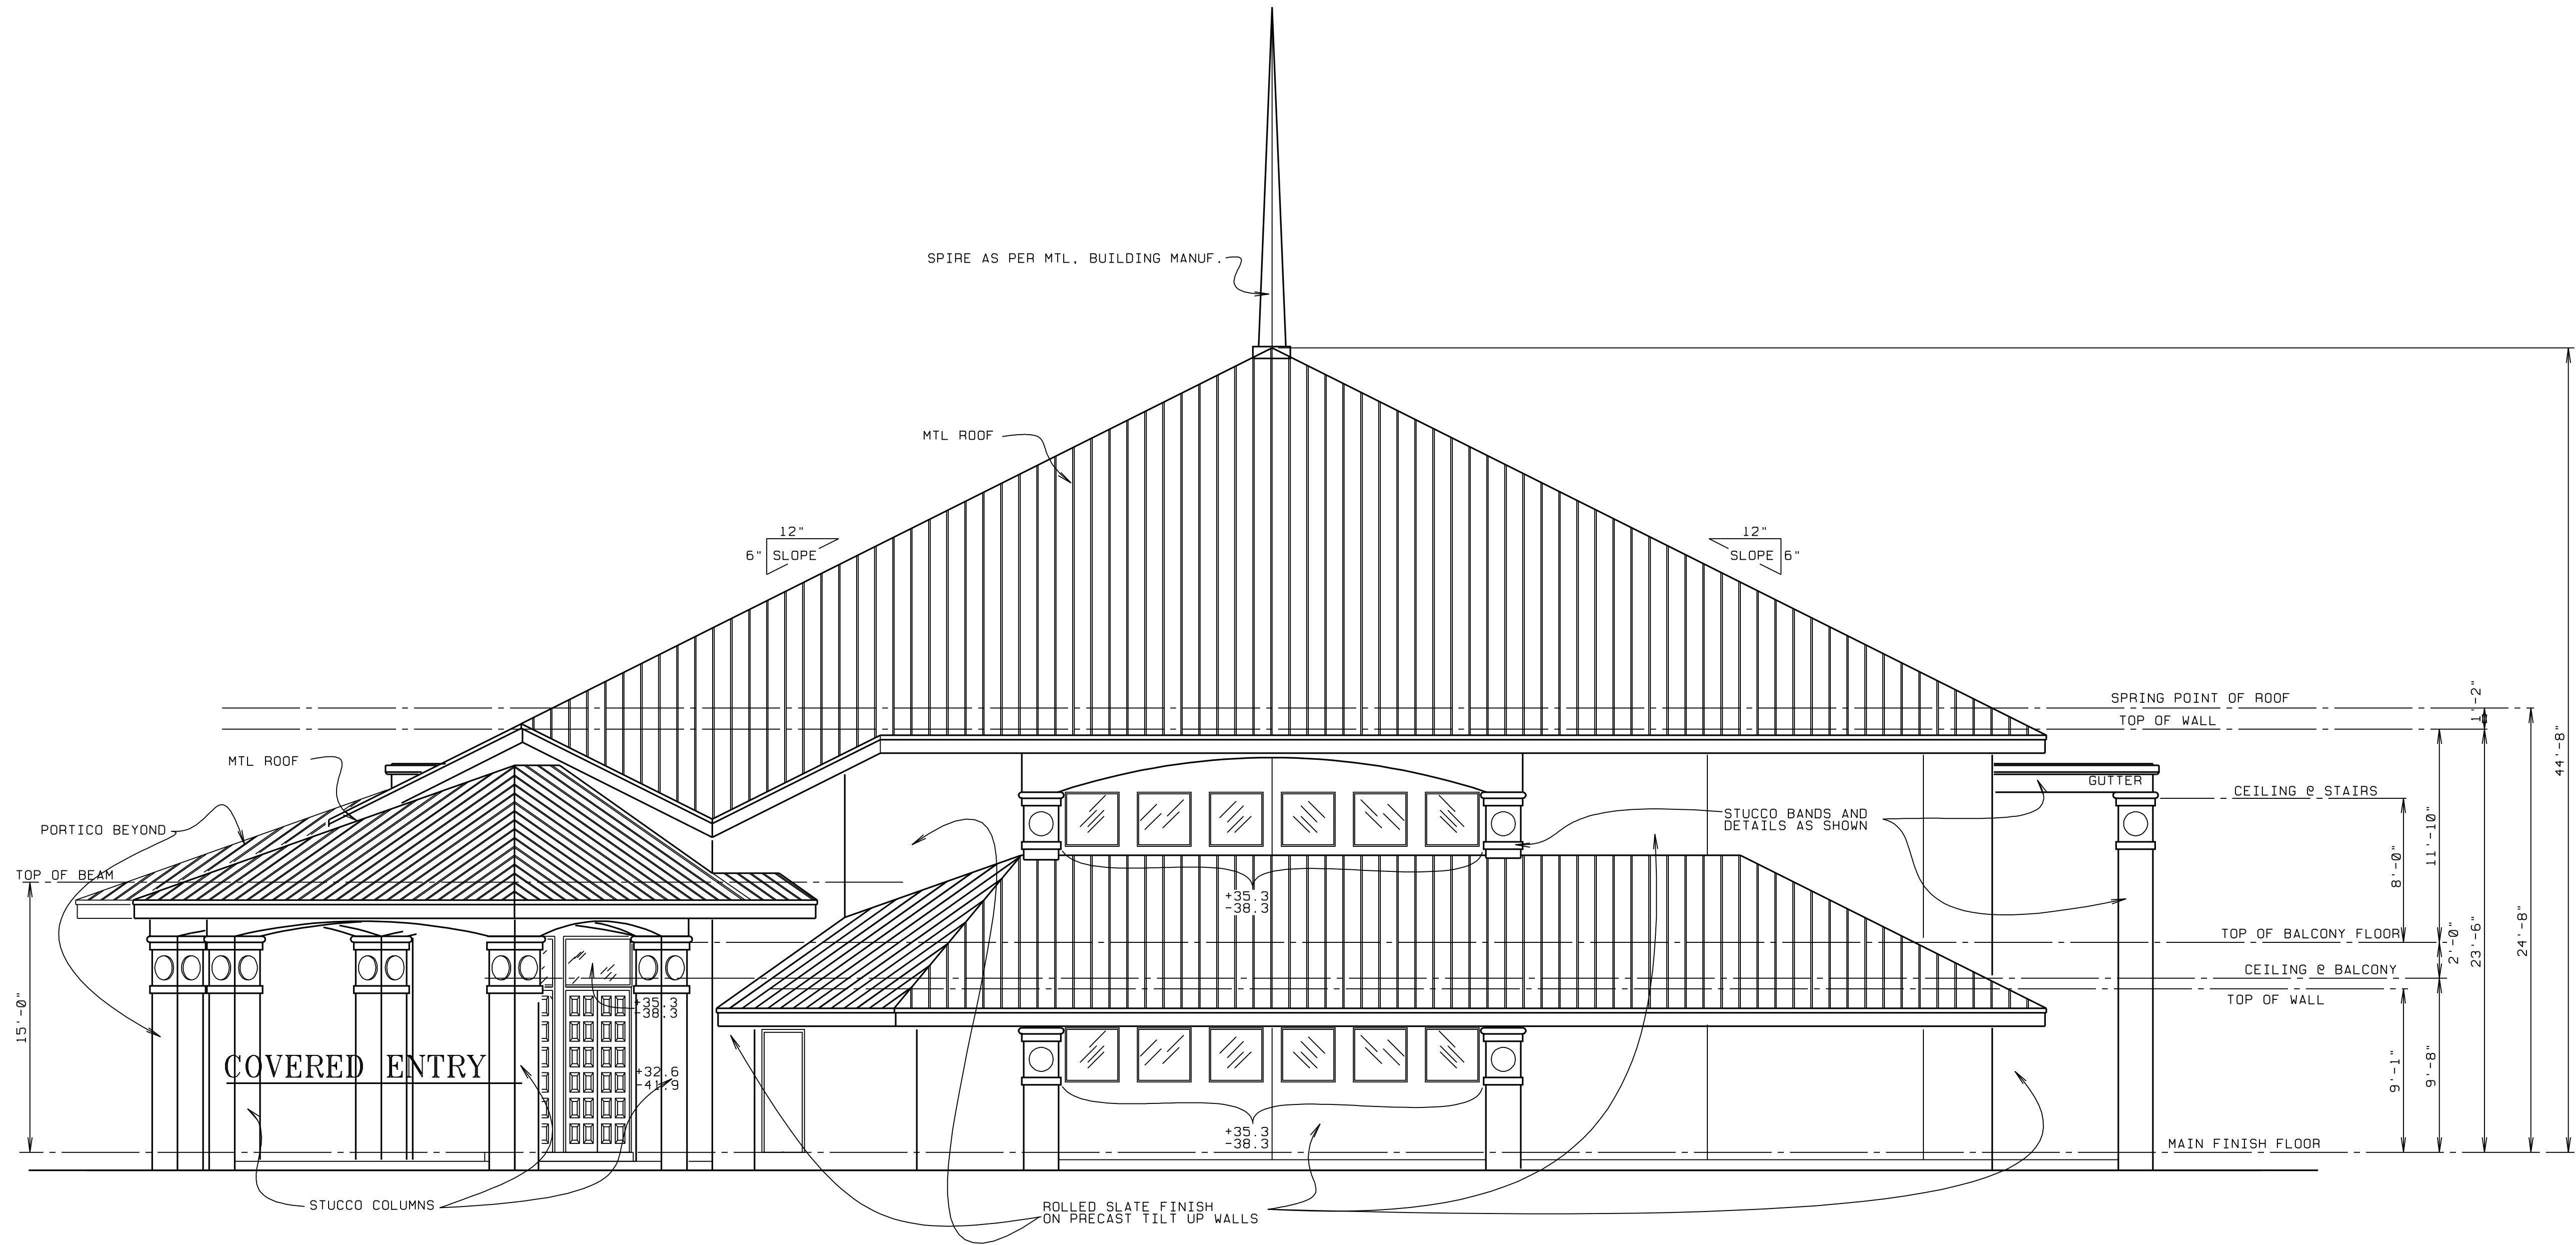

FRONT ELEVATION (EAST)

- SCALE: 3/16" = 1'-0" -


© L. BRUCE KILBY, INC., 2006

PROJ: 05082	REVISD:
DATE: 8/9/06	BY: LRK
7 of 26	

A NEW SANCTUARY FOR:

FLORIDA

L. BRUCE KILBY, DESIGNS

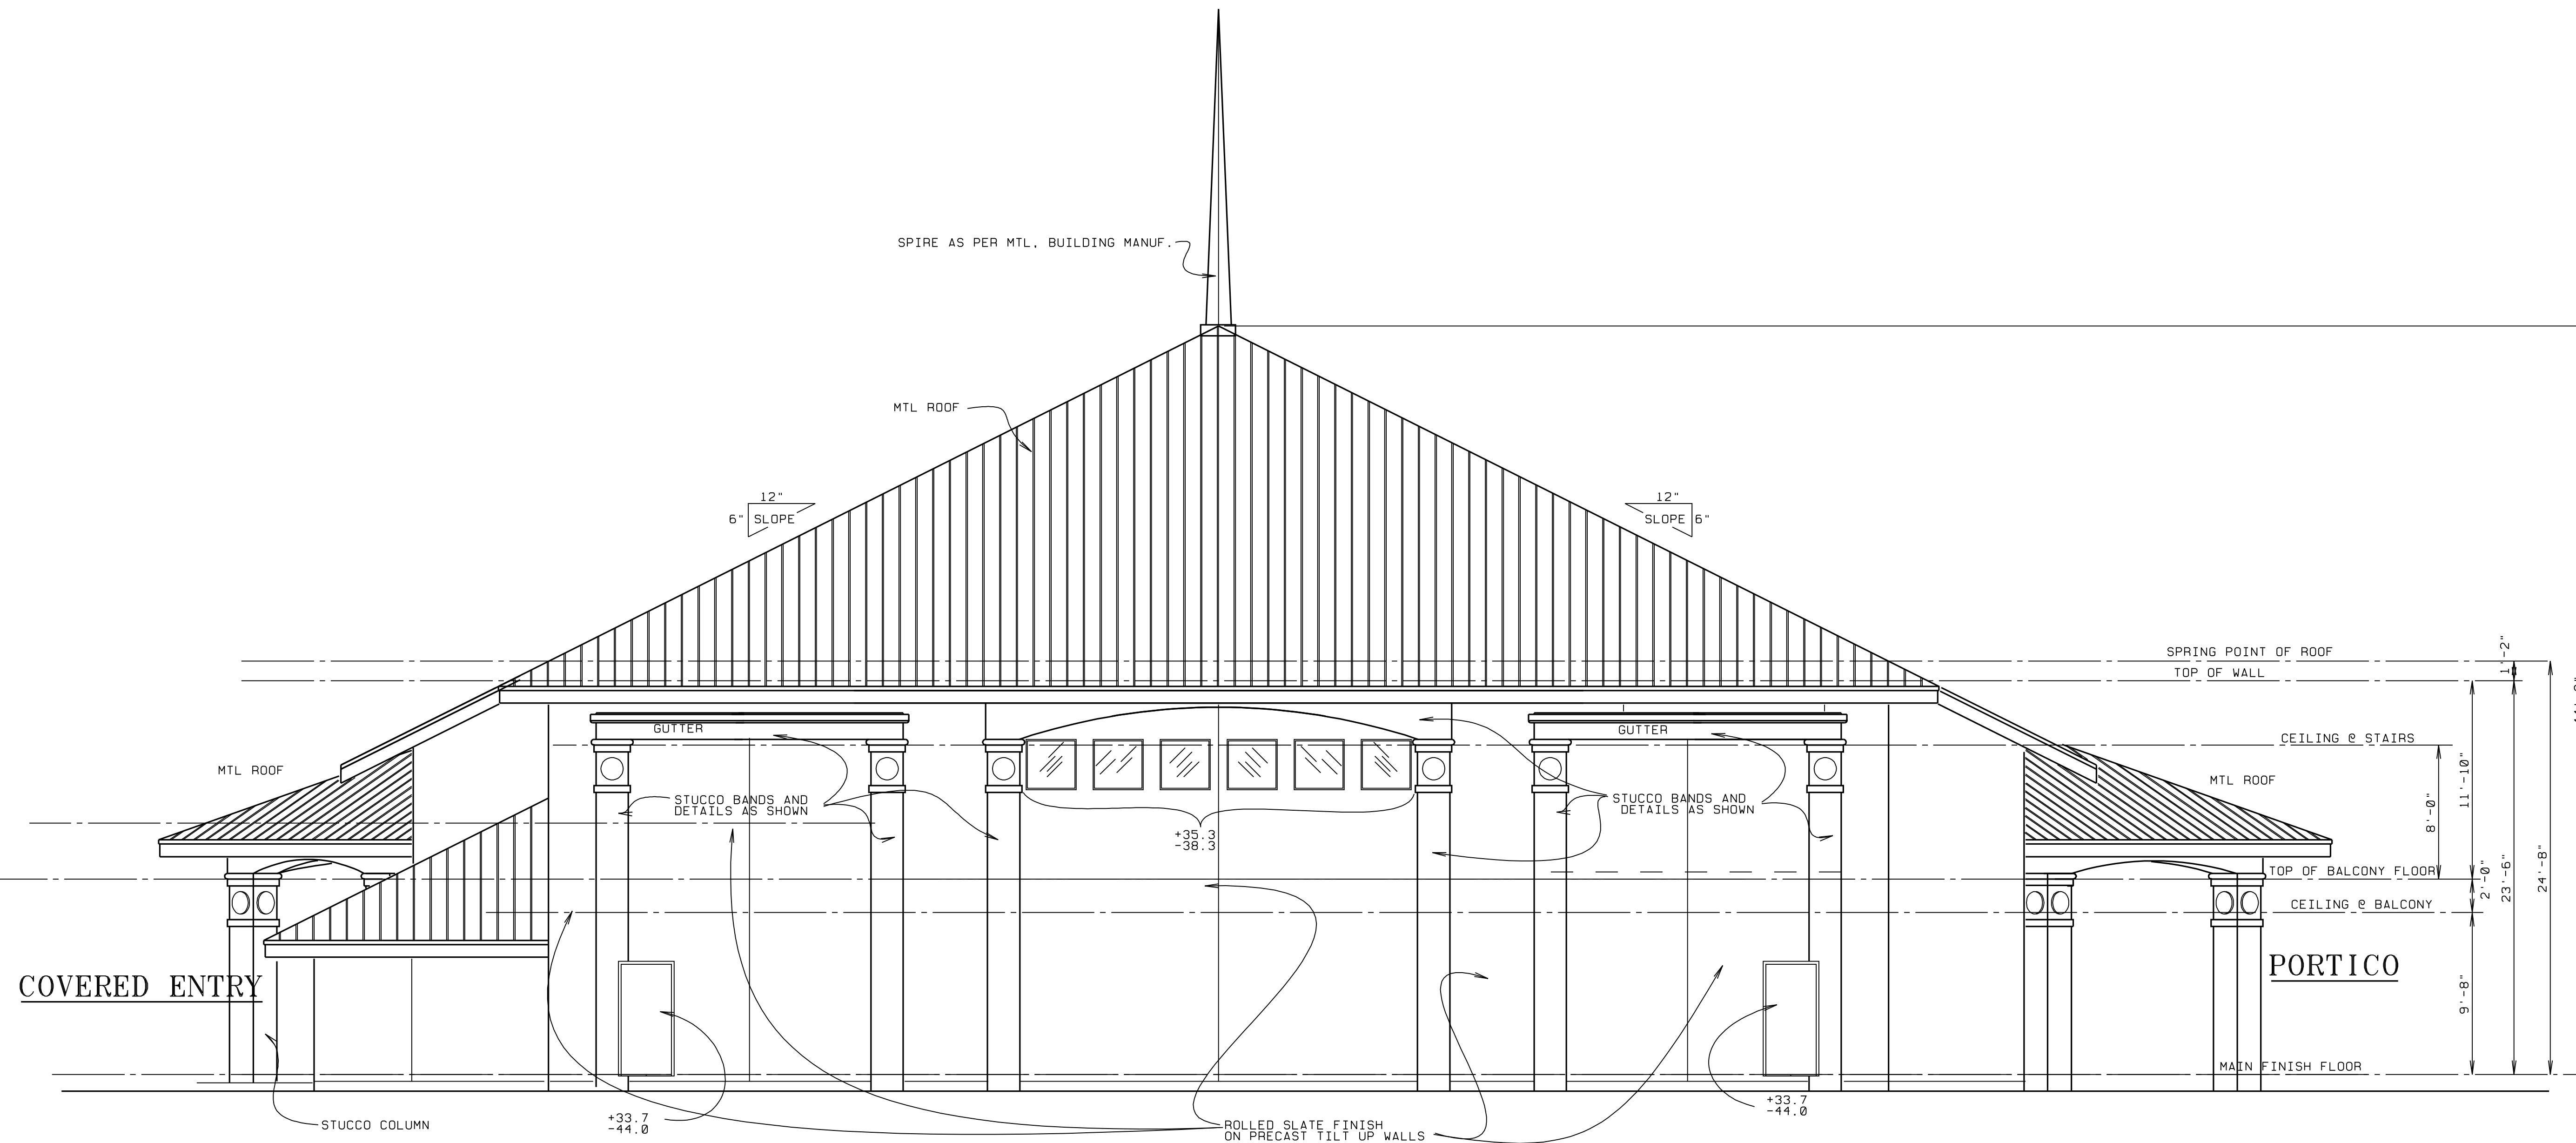

RIGHT SIDE ELEVATION (NORTH)

- SCALE: 3/16" = 1'-0" -


© L. BRUCE KILBY, INC., 2006

PROJ: 05082	REVISD:
8	DATE: 8/9/06
of 26	DRAWN BY: LBK

A NEW SANCTUARY FOR:

FLORIDA

L. BRUCE KILBY, DESIGNS

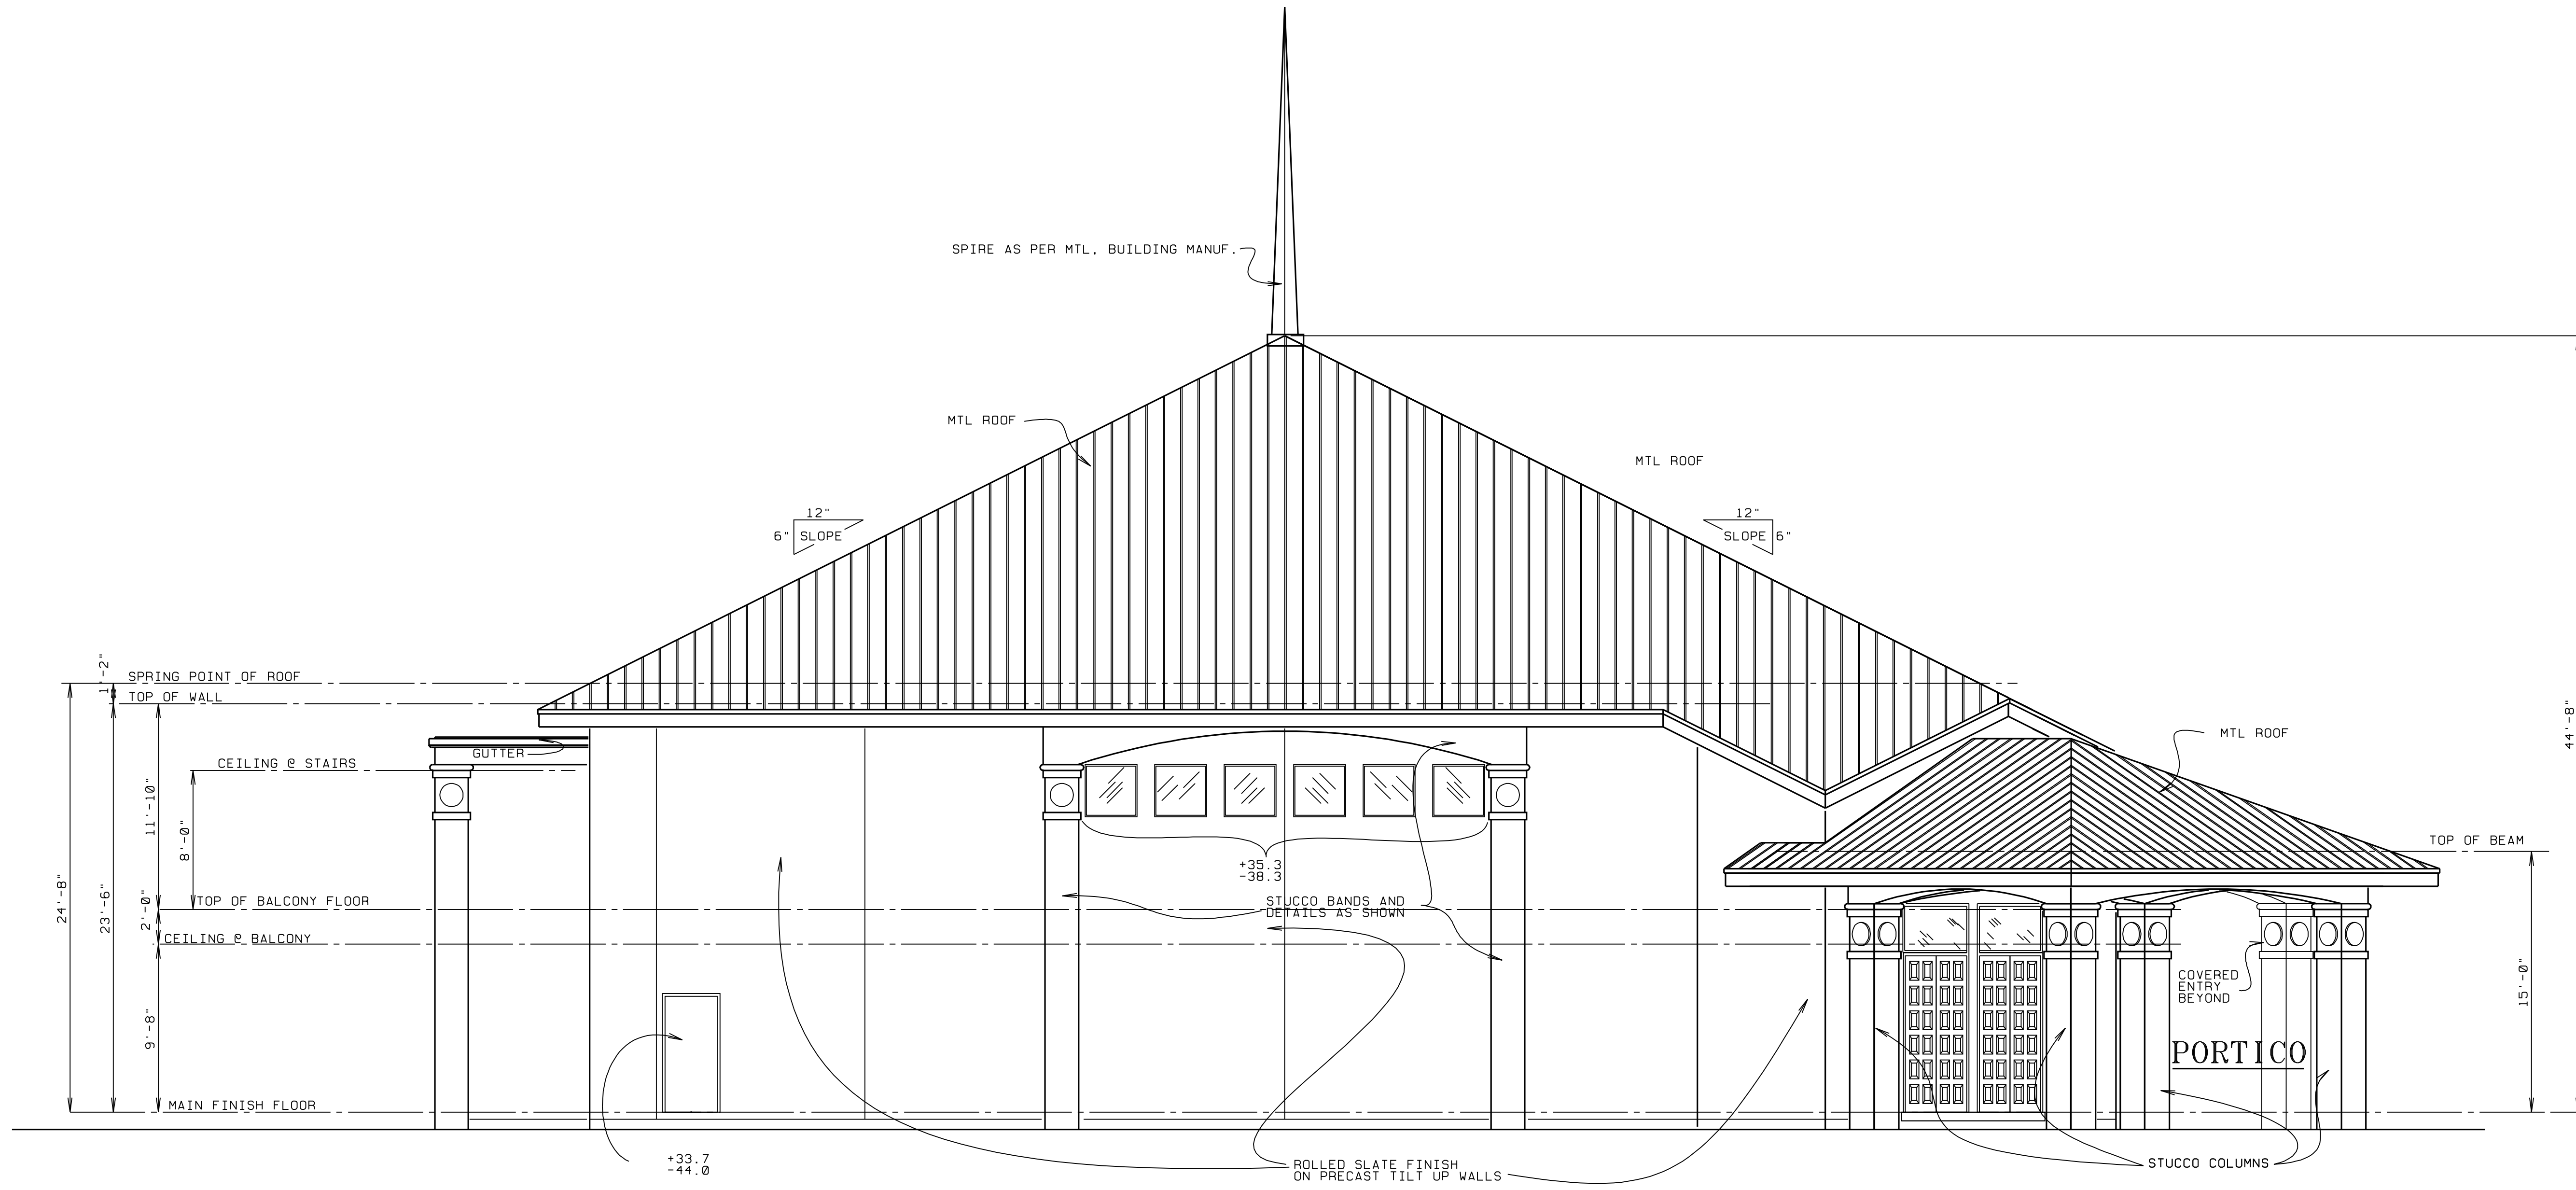

REAR ELEVATION (WEST)

- SCALE: 3/16" = 1'-0" -


© L. BRUCE KILBY, INC., 2006

PROJ: 05082	REVISD:
DATE: 8/9/06	DRAWN BY: LBK
9 of 26	

A NEW SANCTUARY FOR:

FLORIDA

L. BRUCE KILBY, DESIGNS

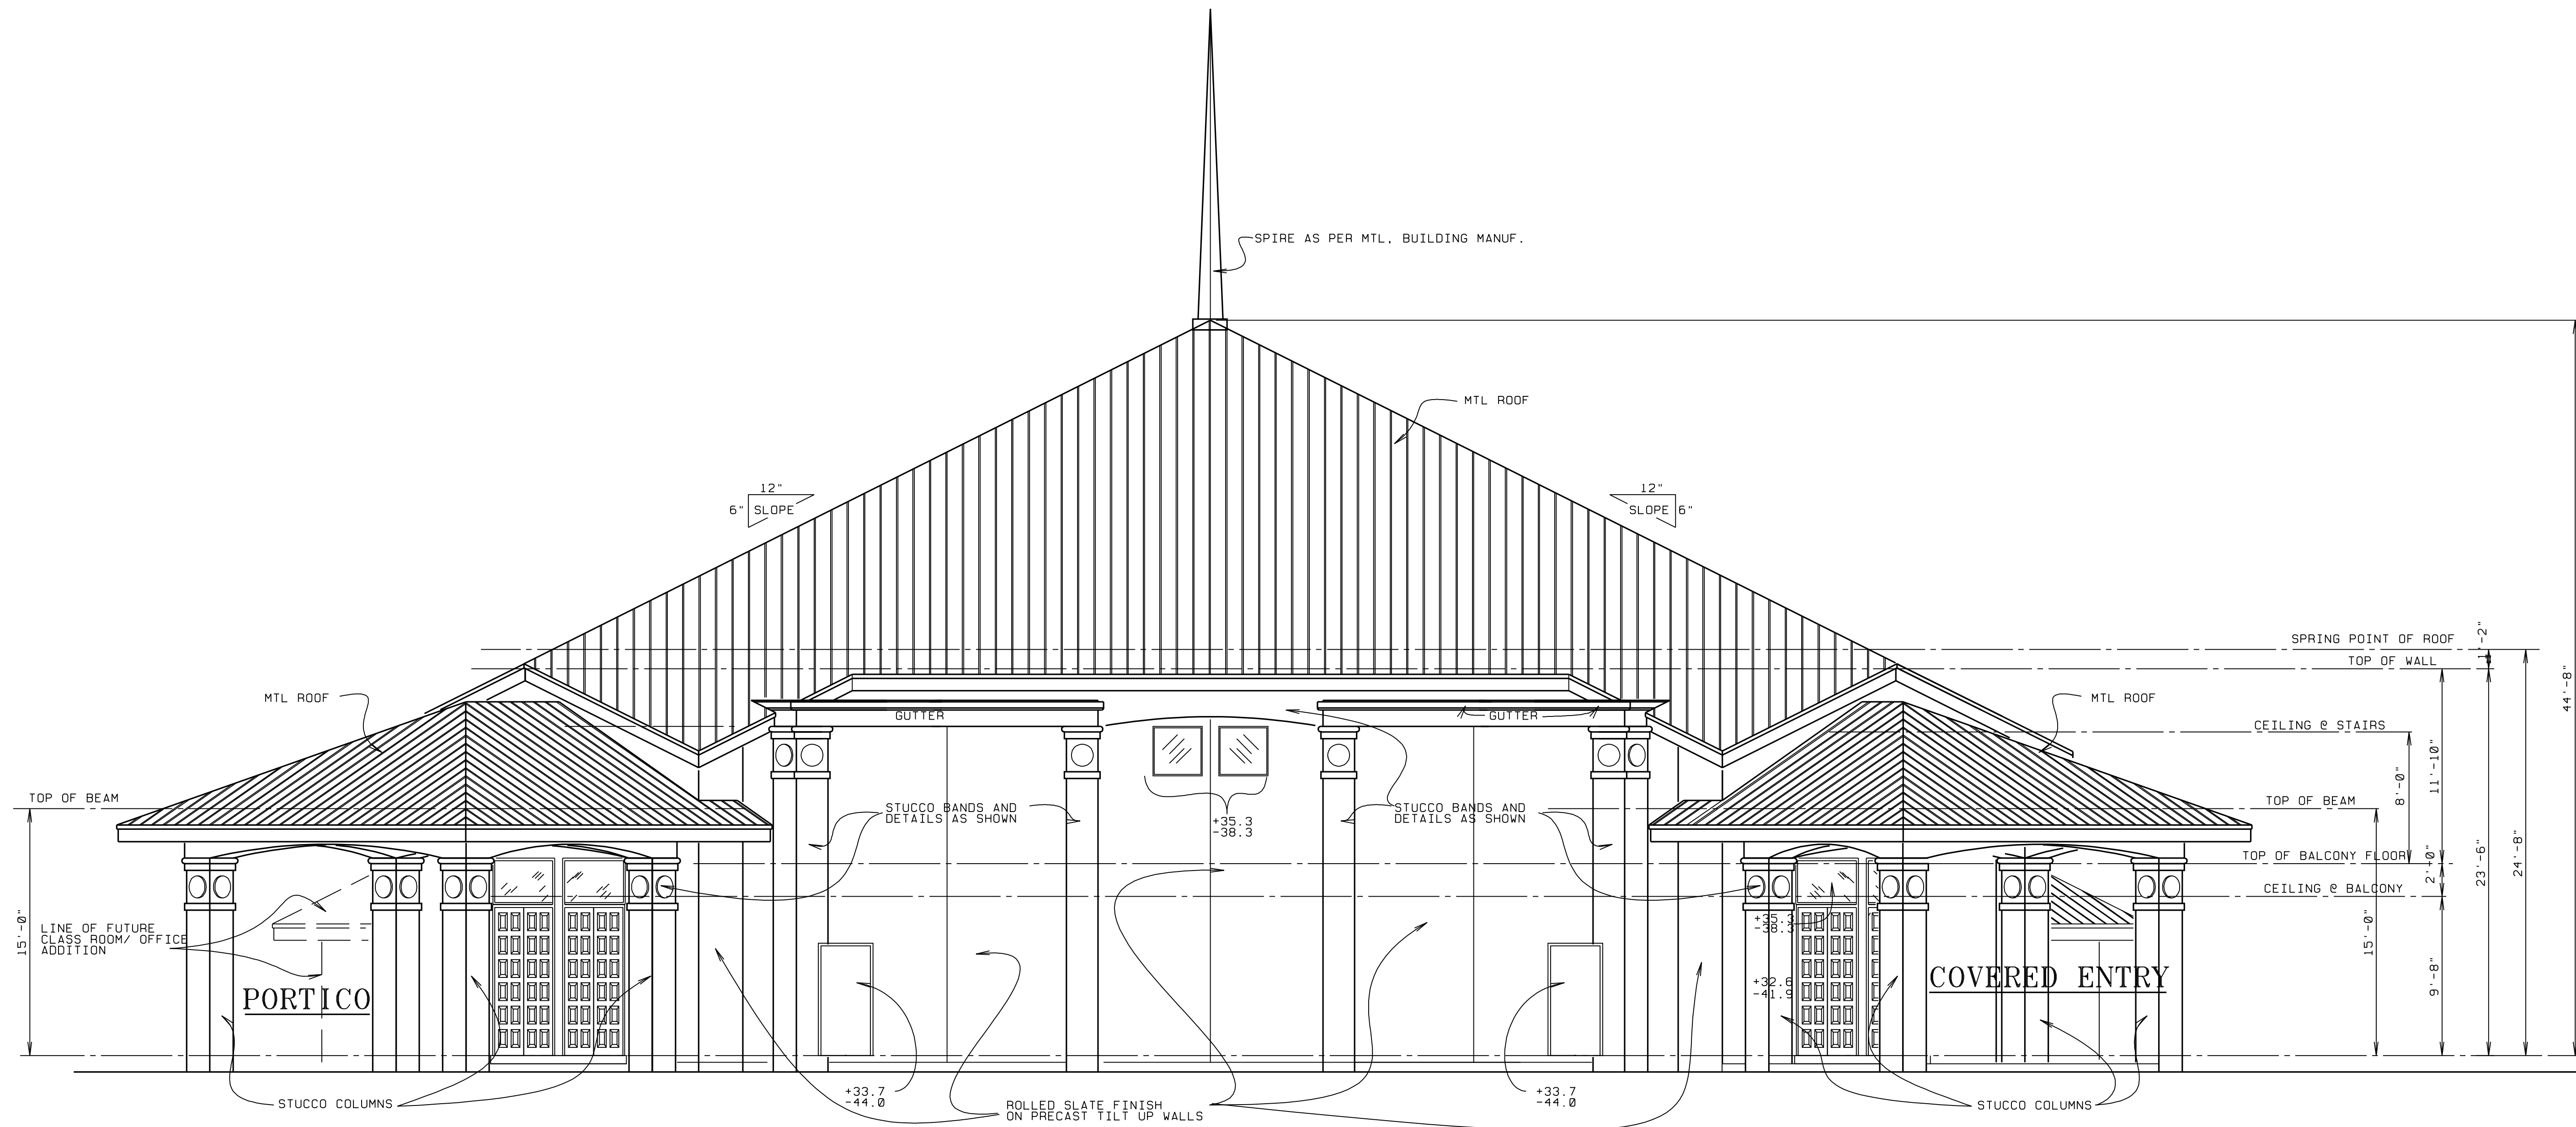

LEFT SIDE ELEVATION (SOUTH)

- SCALE: 3/16" = 1'-0" -

© L. BRUCE KILBY, INC., 2006


PROJ: 05082	REVISD:
DATE: 8/9/06	BY:
DRAWN BY: LBK	

A NEW SANCTUARY FOR:

FLORIDA


L. BRUCE KILBY, DESIGNS

10 of 26

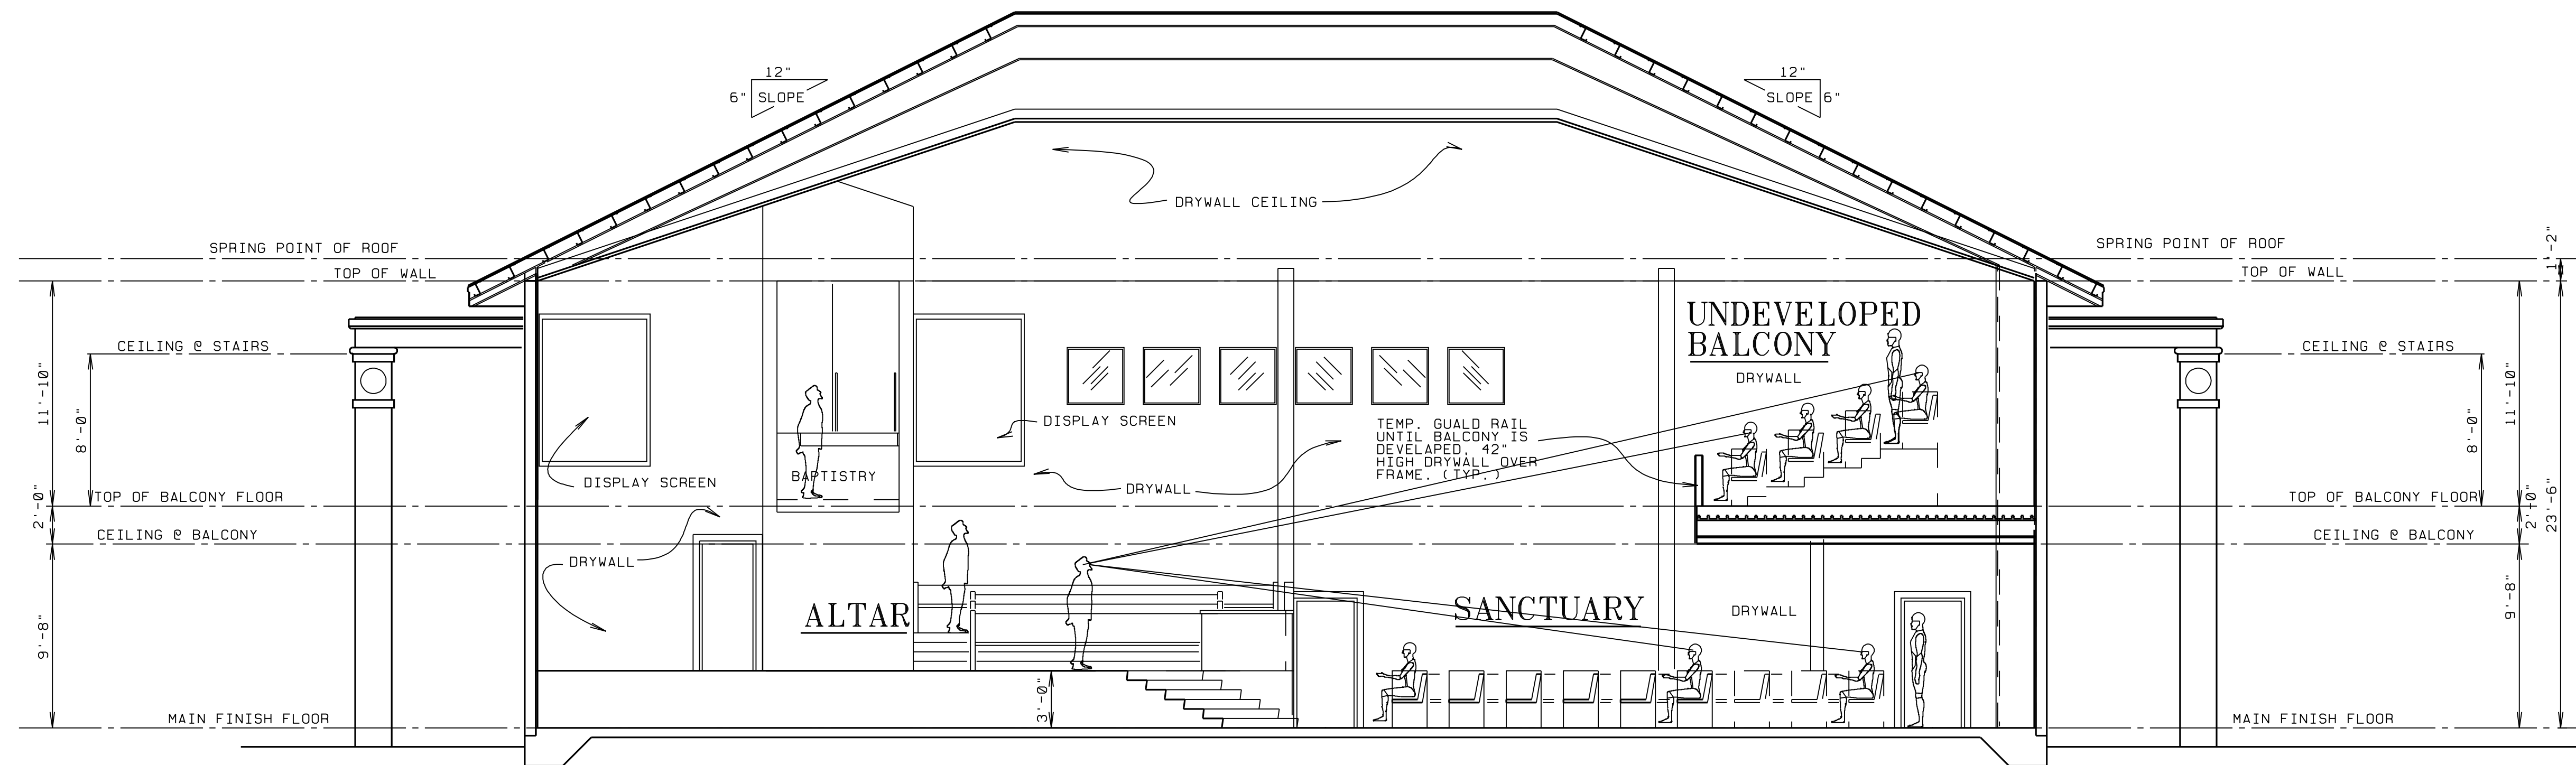

BUILDING CROSS SECTION

- SCALE: 3/16" = 1'-0" -

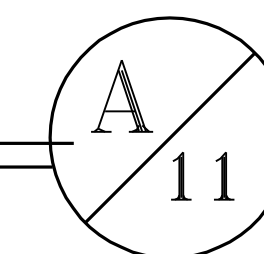

© L. BRUCE KILBY, INC., 2006

PROJ: 05082	REVISED:
DATE: 8/9/06	
DRAWN BY: LBK	

A NEW SANCTUARY FOR:

FLORIDA

L. BRUCE KILBY, DESIGNS

11 of 26